


 
FURNITURE SCHEDULE

ITEM NO	QTY	FURNITURE DESCRIPTION	LENGTH	DEPTH	HEIGHT	FIXED
B-21	1	Bench Cupboard, Technology 1000	1000	580	840	F
B-24	2	Bench Cupboard, Technology 500, 4 Drawers	500	580	840	F
S-06	20	Chair, Linking, F	505	460	445	NF
SK-42	1	Sink, Left Hand Bowl	930	470		F
M-77	1	Top, Bench Technology, 2000 x 600	2000	600	25	F


NOTES:
1. For colour selections refer current Furniture Contractor

THESE DRAWINGS ARE FOR TENDER PURPOSES ONLY AND NOT FOR CONSTRUCTION. THESE DRAWINGS DESCRIBE THE DESIGN INTENT, DESIGN DETAILS AND FINISHES. SIZES AND RELATIONSHIPS OF ROOMS, BUILDING ENVELOPE AND ARCHITECTURAL EXPRESSION. THE SCHOOL FACILITIES STANDARDS MUST BE USED IN CONJUNCTION WITH THESE DRAWINGS.


EACH CODE NUMBER WITH A 'PS' PREFIX CORRESPONDS TO THE RELEVANT PRIMARY SCHOOL FACILITIES STANDARDS ROOM DATA SHEETS DESCRIBING THE FUNCTIONAL AND SERVICE REQUIREMENTS OF EACH ROOM WHICH ARE TO BE INCORPORATED INTO THE WORKS.

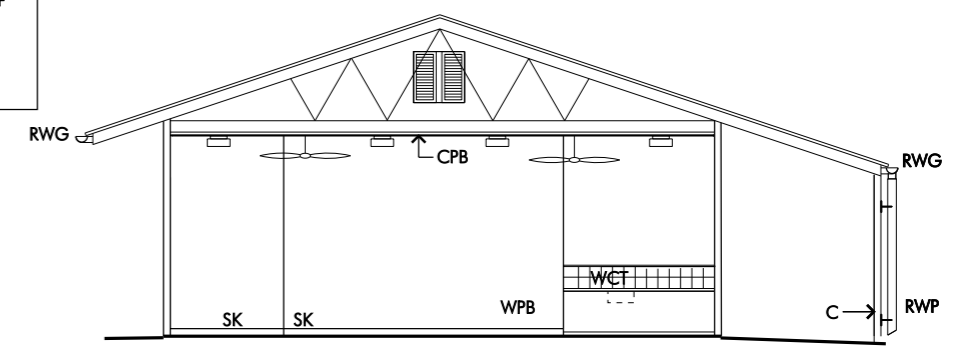


01 SECTION 1

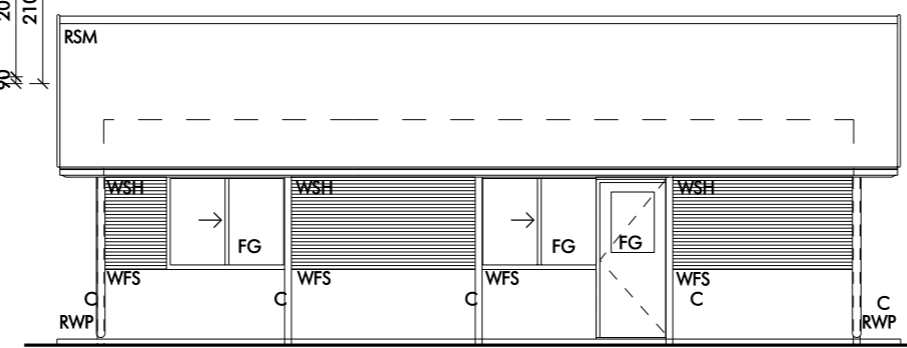


01 ELEVATION 1

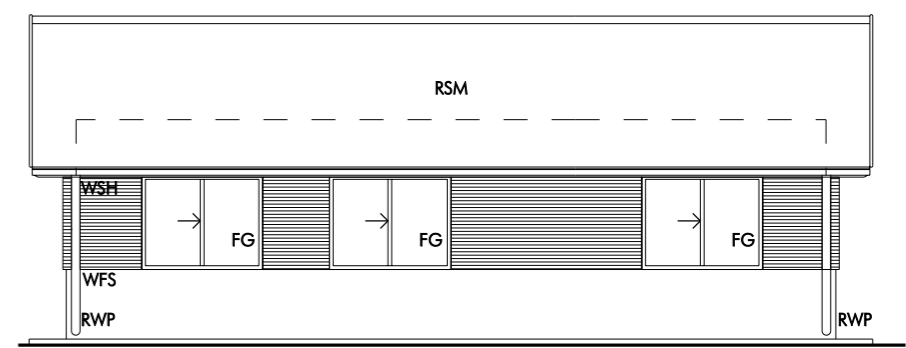

02 ELEVATION 2

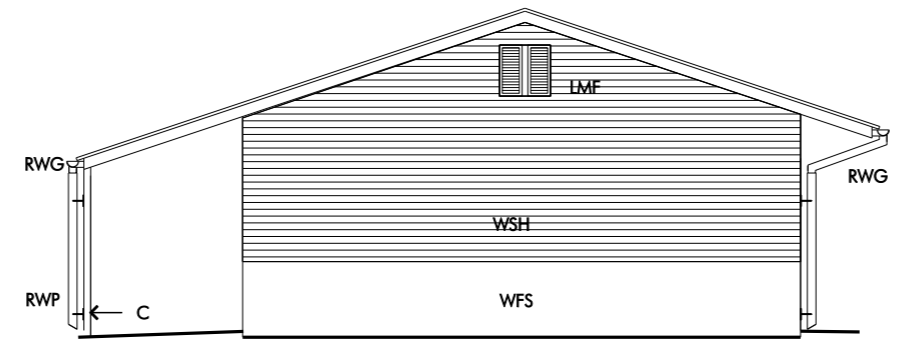

03 ELEVATION 3

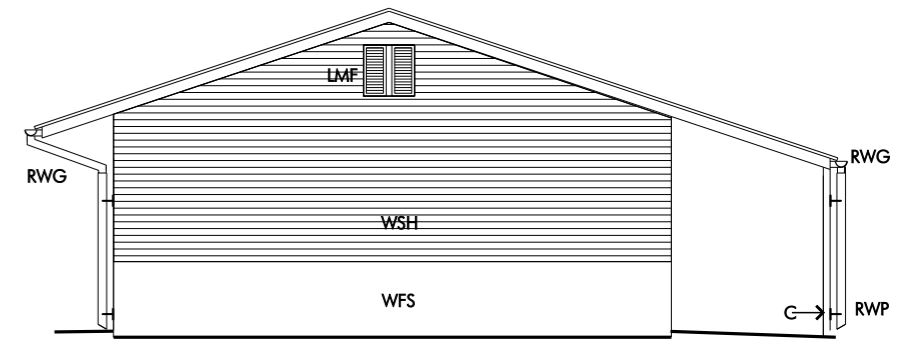

04 ELEVATION 4

APF ALUMINIUM PANEL	CKL PLYWOOD CEILING LINING	LUM LUMINAIRE	RV ROTARY ROOF VENTILATOR	WCT CERAMIC WALL TILES
AW AWNING WINDOW	CPF PERFORATED P.B. CEILING	MVE MECH. VENTILATION EXHAUST COWL	RVS VENTILATED SKYLIGHT	WF WALL FAN
B BOLLARD	DGR GRATED DRAIN	MVD MECH. VENTILATION DUCT	RWG RAINWATER GUTTER	WFS FIRE CEMENT WALL SHEETING
BAL BALUSTRADE	FCF CARPET	MVR MECH. VENTILATION REGISTER	RWP RAINWATER DOWN PIPE	WPA PERFORATED PLYWOOD LINING
BU BUILDING UNDER	FCS STEEL TROWEL CONCRETE	PHA PERFORATED METAL	SC STEEL COLUMN	WPB PLASTERBOARD WALL
C COLUMN	FCT CERAMIC FLOOR TILES	PVC PHOTOVOLTAIC CELL	SK SKIRTING	WPL PLYWOOD WALL LINING
CDT TRANSLUCENT CEILING DIFFUSER	FG FIBRE GLAZING	RBR BARGE ROLL	SKD DUCTED SKIRTING	WPN FINISH BOARD WALL LINING
CDV CEILING DIFFUSER VENT	FSD FIBRE OBSOURE GLAZING	RO ROOF OVER	SNH SUNHOOD	WPP PERFORATED PLASTERBOARD WALL LINING
CDY SKYLIGHT DIFFUSER PANEL	FST FIBRE OBSOURE GLAZING	ROR ROOF CAPPING	SPK SPEAKER	WRS RENDERED BRICKWORK
CF CEILING FAN	FIS INDUSTRIAL SHEET FLOORING	RSM CORRUGATED METAL ROOF SHEETING	TP TIMBER POST	WSH WALL SHEETING-HORIZONTAL
CFS FIRE CEMENT CEILING	FVS VINYL SHEETING	RST CORRUGATED TRANSLUCENT ROOF SHEETING	WBF FACE BRICKWORK	WT WATER TANK
CPW WATER RESISTANT PVC CEILING	HR HANDRAIL		WBS TWO COURSE BRIGHT CANT BRICK SOLDIER COURSE	
CMS CORRUGATED METAL SOFFIT	LMA FIBRE METAL LOUVER			
CPB PLASTERBOARD CEILING	ADJUSTABLE METAL LOUVER			

Copyright in this drawing remains with the Minister for Commerce on behalf of the Crown in right of New South Wales.
This drawing is provided for the purposes of the Building the Education Revolution Program only and may not be used for any other purpose without the express permission of the copyright owner.
The user is responsible for ascertaining the accuracy and suitability of this drawing for their purposes. No responsibility is taken for any errors or omissions and any loss or liability suffered as a result of, or due to reliance on, this drawing.
No responsibility is taken for data integrity, or file and system viruses as a result of the electronic transfer of this drawing.
This statement is an integral part of this drawing. Reproduction of this drawing or any part of it without this statement being included in full will render the information shown in such reproduction invalid and not suitable for use.
These documents were prepared for DDC procurement only.

PROJECT MANAGEMENT
PROGRAMS BRANCH
DESIGN DOCUMENTATION
EDUCATION FACILITIES RESEARCH GROUP
GRAEME HEAD
DIRECTOR - GENERAL



Building the EDUCATION REVOLUTION
BASIC DESIGN RANGE
MULTI PURPOSE SPACE
DRAWING SUMMARY SHEET

SCALE 1:100 AT A3	NO IN SET 1/1
REVISION A	SHEET NO H01
DATE 30.04.09	
DRAWN	VERIFIED

A3