







THESE DRAWINGS ARE FOR TENDER PURPOSES ONLY AND NOT FOR CONSTRUCTION. THESE DRAWINGS DESCRIBE THE DESIGN INTENT, DESIGN DETAILS AND FINISHES, SIZES AND RELATIONSHIPS OF ROOMS, BUILDING ENVELOPE AND ARCHITECTURAL EXPRESSION. THE SCHOOL FACILITIES STANDARDS MUST BE USED IN CONJUNCTION WITH THESE DRAWINGS.

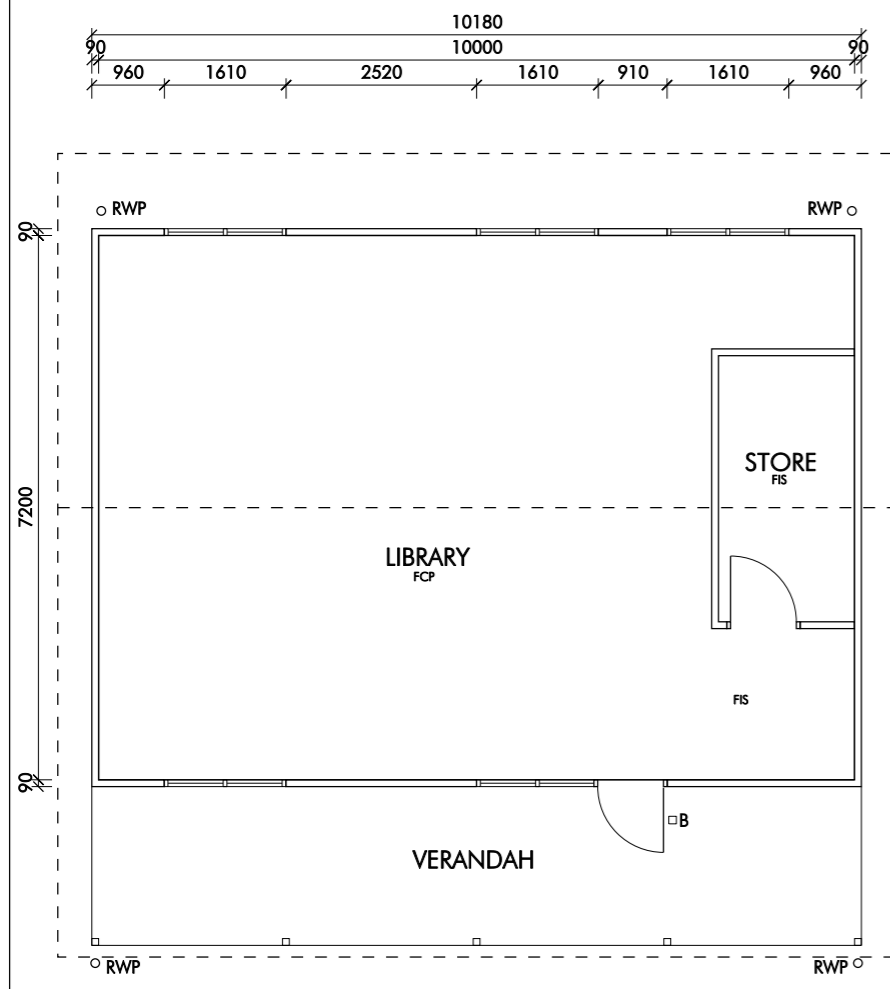

FURNITURE SCHEDULE

ITEM NO	QTY	FURNITURE DESCRIPTION	LENGTH	DEPTH	HEIGHT	FIXED
Ba-25	1	Whiteboard, 2400	2400	25	1200	F
B-21	1	Bench Cupboard, Technology 1000	1000	580	840	F
B-24	3	Bench Cupboard, Technology 500, 4 Drawers	500	580	840	F
B-25	1	Bench Cupboard, Technology 500, 2 Shelves, Open	500	580	840	F
LS-312	1	Shelving, Wall fixed, Starting Bay with 3 Rear WallShelves, 1 Rear Sloping Shelf	900	270	1400	F
LS-322	1	Shelving, Wal fixed, Add on Bay with 3 Rear Wall shelves, 1 Rear Sloping Shelf	900	270	1400	F
LS-343	2	Shelving, Wall fixed, Add on Bay with 3 Forward Sloping Shelves	900	270	1400	F
T-23	5	Table, Art, E	1200	900	650	NF
S-34	1	Drafting Stool, Gas-Lift	460	440	540-750	NF
S-52	5	Chair, Plastic C, Postura (Primary)	389	368	335	NF
S-54	15	Chair, Plastic E, Postura (Primary)	506	482	405	NF
Tr-00	1	Trolley, Library	780	485	820	NF
C-29	1	Cabinet, Foolsap Filing, 4 Drawer	465	615	1320	NF
SK-42	1	Sink, Left Hand Bowl	930	470		F
M-77	1	Top, Bench Technology, 2000 x 600	2000	600	25	F
D-09	1	Display panel, Fabric, no frame, 1800	900	30	1800	F
D-09V	12	Display panel, Fabric, no frame, 1800	1800	30	900	F

NOTES:
1. For colour selections refer current Furniture Contractor
2. *LS-31, 32 Insert quantity, Starting Bays and Add on Bays to total 6.

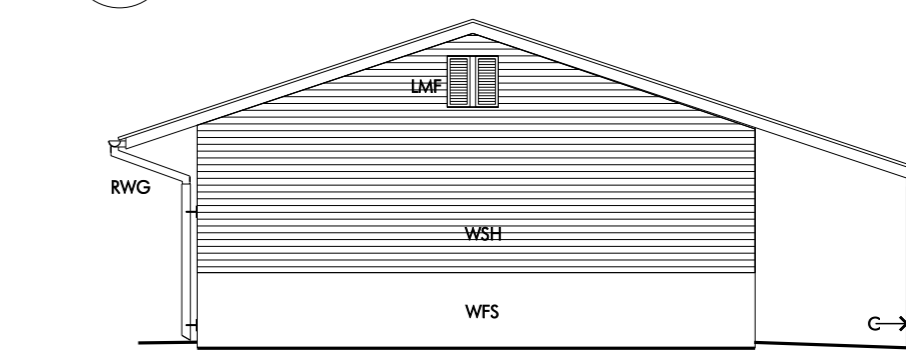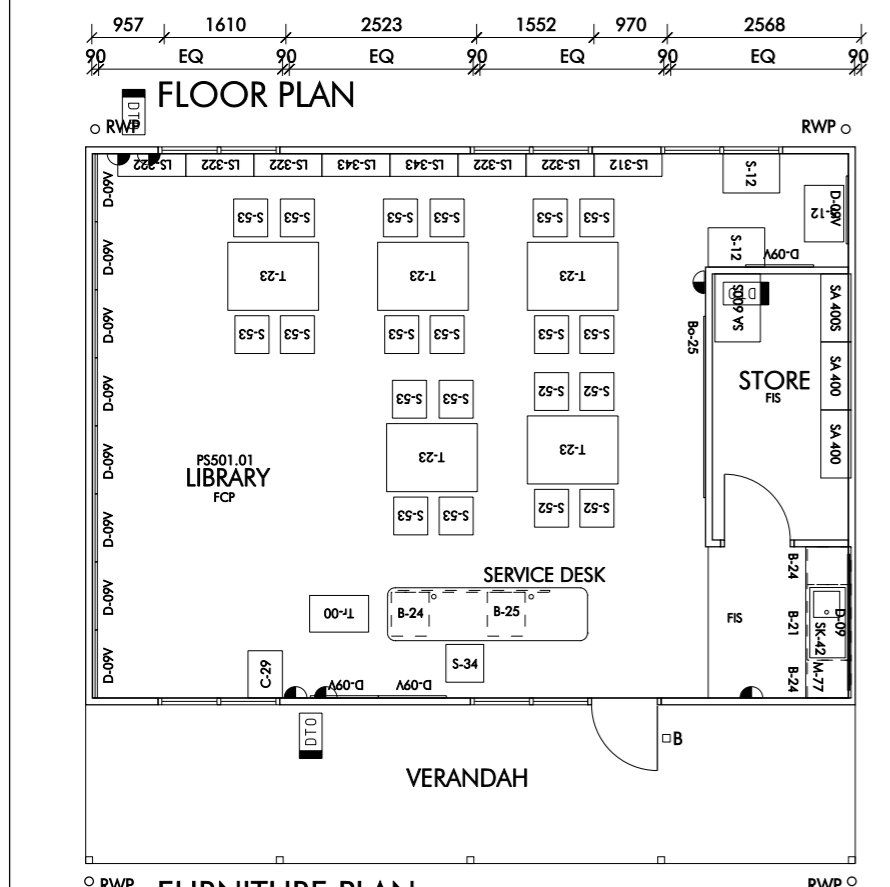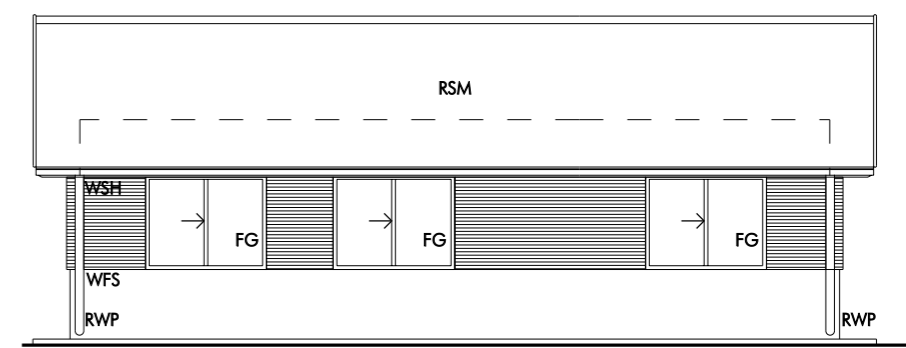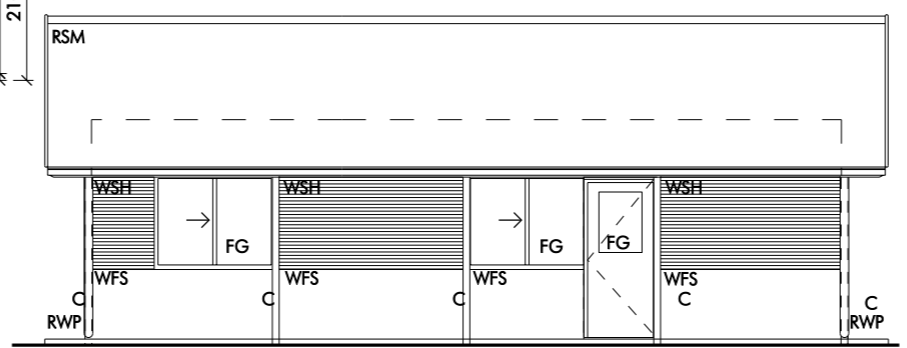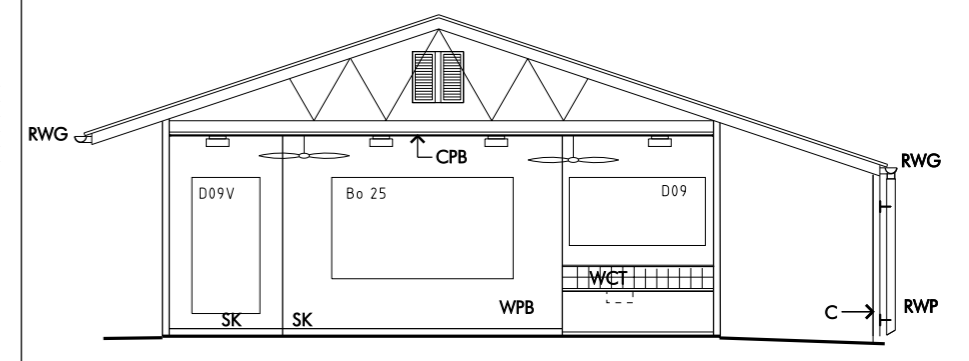

APF ALUMINIUM PANEL	CKL PLYWOOD CEILING LINING	LUMV LUMINAIRE	RV ROTARY ROOF VENTILATOR	WCT CERAMIC WALL TILES
AW AWNING WINDOW	CPF PERFORATED P.A. CEILING	MVE MECH. VENTILATION EXHAUST COVWL	RVS VENTILATED SKYLIGHT	WF WALL FAN
B BOLLARD	DGR GRATED DRAIN	MVD MECH. VENTILATION DUCT	RWG RAINWATER GUTTER	WFS FIRE CEMENT WALL SHEETING
BAL BALUSTRADE	FCF CARPET	MVR MECH. VENTILATION REGISTER	RWP RAINWATER DOWN PIPE	WPA PERFORATED PLYWOOD LINING
BU BUILDING UNDER	FCS STEEL TROWEL CONCRETE	PK PERFORATED METAL	SC STEEL COLUMN	WPB PLASTERBOARD WALL
CCC CIRCULAR CONCRETE COLUMN	FCT CERAMIC FLOOR TILES	PVC PHOTOVOLTAIC CELL	SK SKIRTING	WPL PLYWOOD WALL LINING
CDT TRANSLUCENT CEILING DIFFUSER	FRD FRIED GLAZING	RR RIBGE ROLL	SKD DUCTED SKIRTING	WPN FINBOARD WALL LINING
CEV CEILING DIFFUSER VENT	FSO FRIED OBSOURE GLAZING	RO ROOF OVER	SNH SUNHOOD	WPP PERFORATED PLASTERBOARD WALL LINING
CDY SKYLIGHT DIFFUSER PANEL	FTB TIMBER BOARD FLOORING	RIC RIDGE CAPPING	SFK SPREADER	WSP PERFORATED PLASTERBOARD WALL LINING
CF CEILING FAN	PVF VINYL SHEETING FOAM BACKED	RF ROOF FLASHING	TP TIMBER POST	WWS RENDERED BRICKWORK
CFS FIRE CEMENT CEILING	PVS VINYL SHEETING	RSM CORRUGATED METAL ROOF SHEETING	WBF FACE BRICKWORK	WSV METAL WALL SHEETING-VERTICAL CORRUGATIONS
CPW WATER RESISTANT FVC CEILING	HR HANDRAIL	RST CORRUGATED TRANSLUCENT ROOF SHEETING	WBS TWO COURSE BRIGHT CANT BRICK SOLDIER COURSE	WT WATER TANK
CMS CORRUGATED METAL SOFFIT	LMF LINED METAL LOUVER			
CPB PLASTERBOARD CEILING	LAJ ADJUSTABLE METAL LOUVER			

Copyright in this drawing remains with the Minister for Commerce on behalf of the Crown in right of New South Wales.
This drawing is provided for the purposes of the Building the Education Revolution Program only and may not be used for any other purpose without the express permission of the copyright owner.
The user is responsible for ascertaining the accuracy and suitability of this drawing for their purposes. No responsibility is taken for any errors or omissions and any loss or liability suffered as a result of, or due to reliance on, this drawing.
No responsibility is taken for data integrity, or file and system viruses as a result of the electronic transfer of this drawing.
This statement is an integral part of this drawing. Reproduction of this drawing or any part of it without this statement being included in full will render the information shown in such reproduction invalid and not suitable for use.
These documents were prepared for DDC procurement only.

PROJECT MANAGEMENT
PROGRAMS BRANCH
DESIGN DOCUMENTATION
EDUCATION FACILITIES RESEARCH GROUP
GRAEME HEAD
DIRECTOR - GENERAL



Building the EDUCATION REVOLUTION
BASIC DESIGN RANGE LIBRARY
DRAWING SUMMARY SHEET

SCALE 1:100 AT A3	NO IN SET 1/1
REVISION A	SHEET NO L01
DATE 29.04.09	DRAWN VERIFIED

A3