


TYPE 1 LINEAR PLAN A

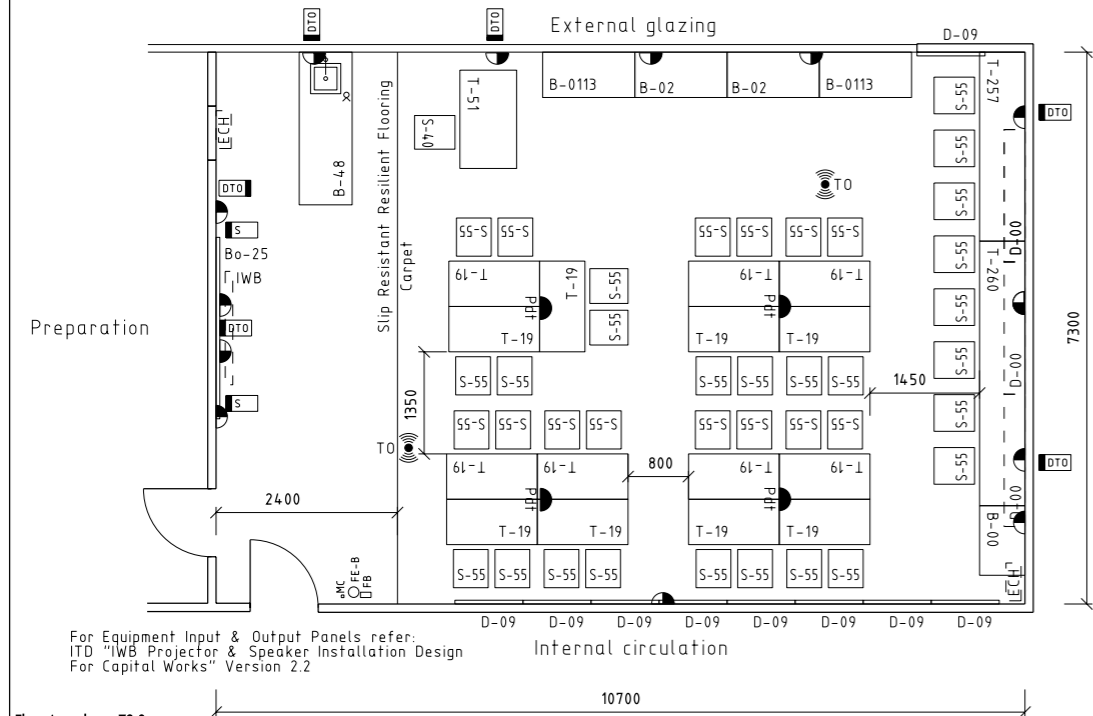


SCIENCE LEARNING SPACE - TYPE 2D


THESE DRAWINGS ARE FOR TENDER PURPOSES ONLY AND NOT FOR CONSTRUCTION. THESE DRAWINGS DESCRIBE THE DESIGN INTENT, DESIGN DETAILS AND FINISHES, SIZES AND RELATIONSHIPS OF ROOMS, BUILDING ENVELOPE AND ARCHITECTURAL EXPRESSION. THE SCHOOL FACILITIES STANDARDS MUST BE USED IN CONJUNCTION WITH THESE DRAWINGS.

Floor Area shown 78.1 sq.m


Floor Area shown 78.0 sq.m

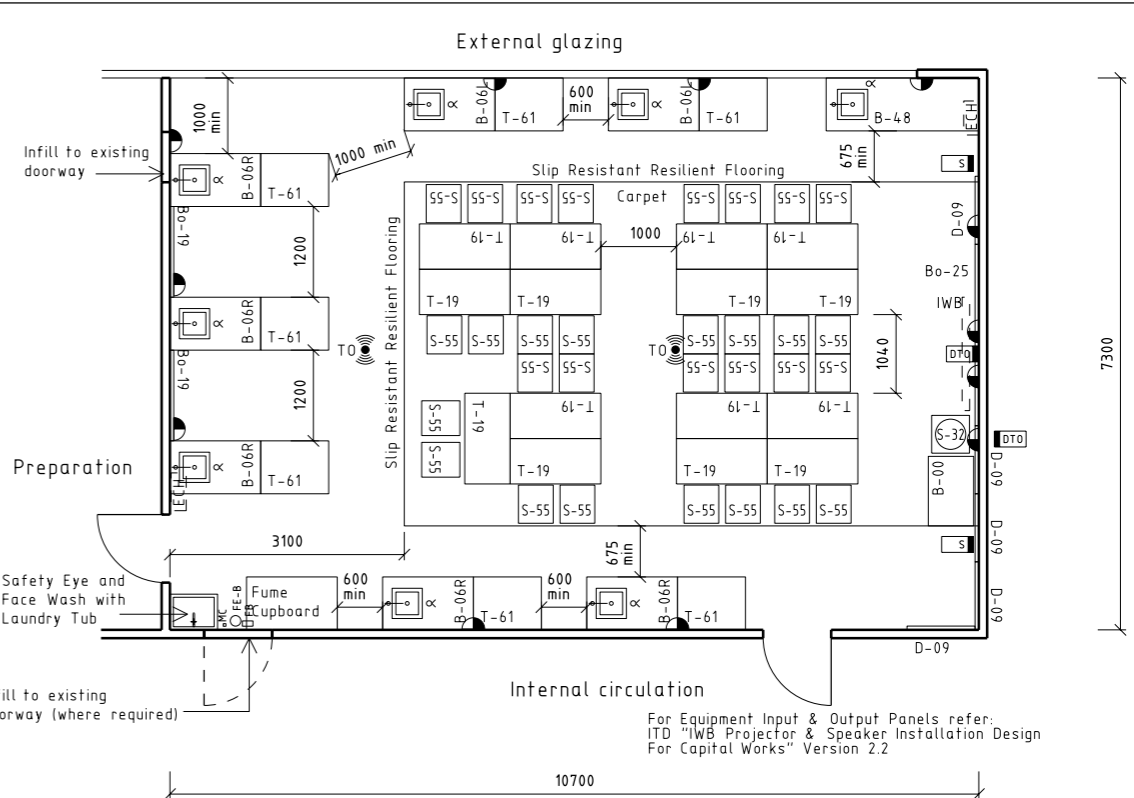

TYPE 1B WITH FC

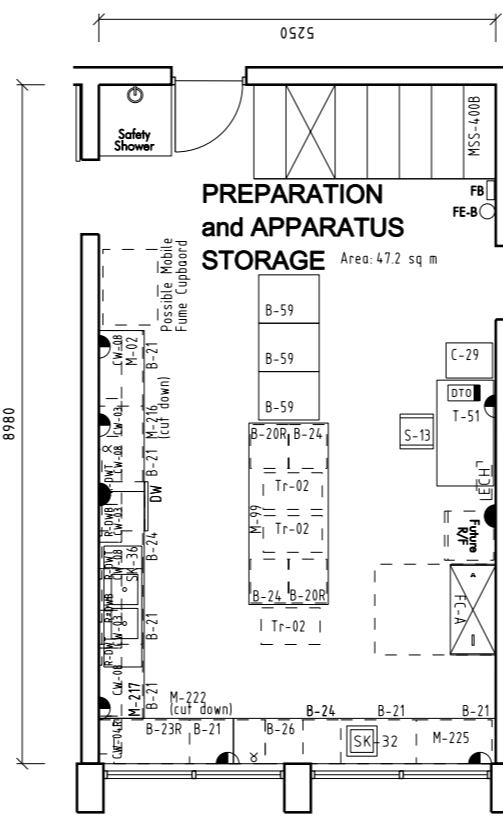

PREPARATION

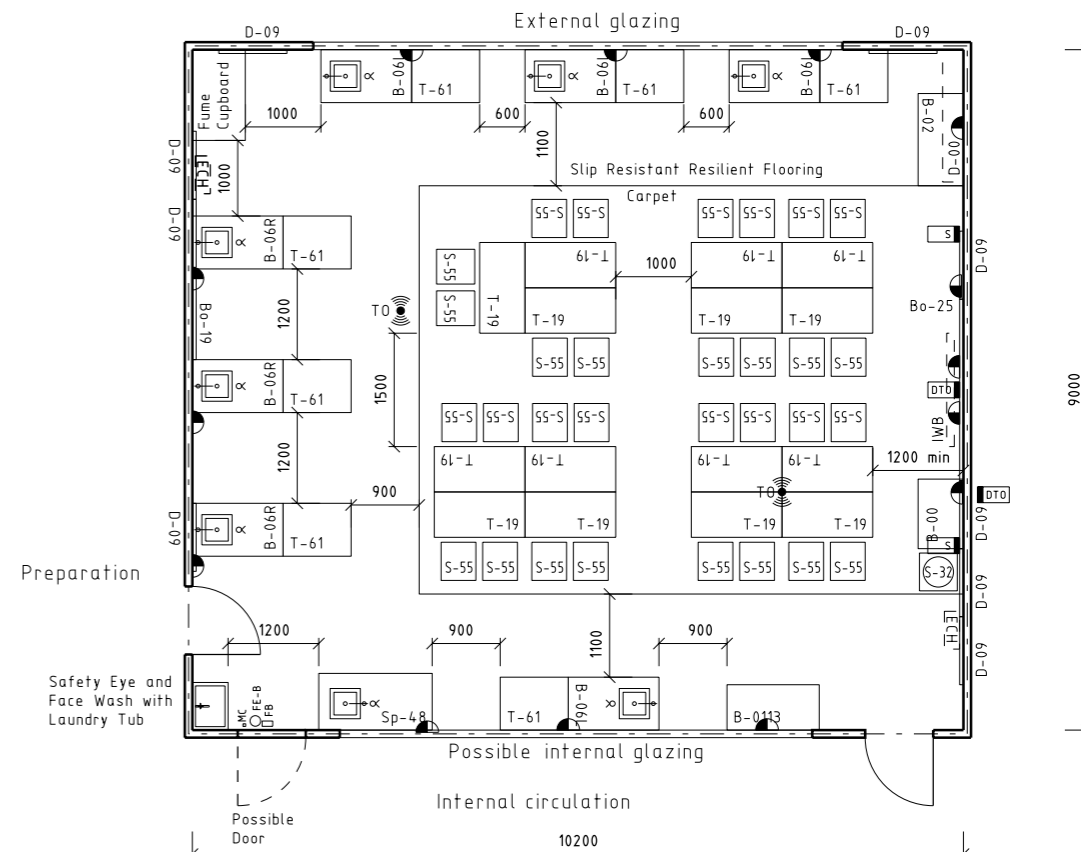

TYPE 1 SQUARE TYPE C SPECIAL

For Equipment Input & Output Panels refer: ITD "IWB Projector & Speaker Installation Design For Capital Works" Version 2.2

<p>A3</p> <p>0 10 20 30 40 50 60 70 80 90 100</p>	<p>ALF ALUMINIUM PANEL</p> <p>AW AWNING WINDOW</p> <p>B BOLLARD</p> <p>BAL BALUSTRADE</p> <p>BU BUILDING UNDER</p> <p>CCC CIRCULAR CONCRETE COLUMN</p> <p>CCD TRANSLUCENT CEILING DIFFUSER</p> <p>CDV CEILING DIFFUSER VENT</p> <p>CDY SKYLIGHT DIFFUSER PANEL</p> <p>CF CEILING FAN</p> <p>CFS FIRE CEMENT CEILING</p> <p>CPW WATER RESISTANT PVC CEILING</p> <p>CMS CORRUGATED METAL SOFFIT</p> <p>CPS PLASTERBOARD CEILING</p>	<p>CL PLYWOOD CEILING LINING</p> <p>CPR PERFORATED P.A. CEILING</p> <p>DGR GRATED DRAIN</p> <p>FCP CARPET</p> <p>FCS STEEL TROWEL CONCRETE</p> <p>FCT CERAMIC FLOOR TILES</p> <p>FGD FIBRE GLAZING</p> <p>FGB FIBRE GLASS GLAZING</p> <p>FTB TIMBER BOARD FLOORING</p> <p>FVF VINYL SHEETING FOAM BACKED</p> <p>PVS VINYL SHEETING</p> <p>HR HANDRAIL</p> <p>LMD FIBRE METAL LOUVER</p> <p>LMA ADJUSTABLE METAL LOUVER</p>	<p>LUM LUMINAIRE</p> <p>MVE MECH. VENTILATION EXHAUST COVUL</p> <p>MVD MECH. VENTILATION DUCT</p> <p>MVR MECH. VENTILATION REGISTER</p> <p>PHV PHOTOVOLTAIC CELL</p> <p>RBR BARGE ROLL</p> <p>RIC ROOF CURPING</p> <p>RO ROOF OVER</p> <p>RMC ROOF CURPING</p> <p>RFM CORRUGATED METAL ROOF</p> <p>RST CORRUGATED TRANSLUCENT ROOF SHEETING</p>	<p>RV ROTARY ROOF VENTILATOR</p> <p>RVS VENTILATED SKYLIGHT</p> <p>RWG RAINWATER GUTTER</p> <p>RWP RAINWATER DOWN PIPE</p> <p>SC SKIRTING</p> <p>SKD DUCTED SKIRTING</p> <p>SHD SUNHOOD</p> <p>SPK SPEAKER</p> <p>TP TIMBER POST</p> <p>WBF FACE BRICKWORK</p> <p>WBS TWO COURSE HIGH CANT BRICK SOLDIER COURSE</p> <p>WT WATER TANK</p>	<p>WCT CERAMIC WALL TILES</p> <p>WFF WALL FAN</p> <p>WFS FIRE CEMENT WALL SHEETING</p> <p>WPA PERFORATED PLYWOOD LINING</p> <p>WPL PLYWOOD WALL LINING</p> <p>WPN FINBOARD WALL LINING</p> <p>WPP PERFORATED PLASTERBOARD WALL LINING</p> <p>WRS RENDERED BRICKWORK</p> <p>WSV METAL WALL SHEETING-VERTICAL CORRUGATIONS</p> <p>WT WATER TANK</p>	<p>Copyright in this drawing remains with the Minister for Commerce on behalf of the Crown in right of New South Wales.</p> <p>This drawing is provided for the purposes of the Building the Education Revolution Program only and may not be used for any other purpose without the express permission of the copyright owner.</p> <p>The user is responsible for ascertaining the accuracy and suitability of this drawing for their purposes. No responsibility is taken for any errors or omissions and any loss or liability suffered as a result of, or due to reliance on, this drawing.</p> <p>No responsibility is taken for data integrity, or file and system viruses as a result of the electronic transfer of this drawing. This statement is an integral part of this drawing. Reproduction of this drawing or any part of it without this statement being included in full will render the information shown in such reproduction invalid and not suitable for use.</p> <p>These documents were prepared for DDC procurement only.</p>	<p>PROJECT MANAGEMENT</p> <p>PROGRAMS BRANCH</p> <p>DESIGN DOCUMENTATION</p> <p>BUILDING DESIGN SERVICES</p> <p>PETER MCILLOID GOVERNMENT ARCHITECT</p> <p>GRAEME HEAD DIRECTOR - DESIGN</p>	<p>Building the EDUCATION REVOLUTION</p> <p>BUILDING THE EDUCATION REVOLUTION</p> <p>A SCIENCE CENTRE FOR THE 21ST CENTURY SECONDARY SCHOOL</p>	<p>SCALE 1:100@A3</p> <p>NO IN SET</p> <p>REVISION</p> <p>DATE MAY 2009</p> <p>DRAWN GAO</p> <p>VERIFIED PTS</p> <p>SHEET NO 1</p>
	<p>NSW Department of Commerce</p> <p>DET</p>								