


NO	REVISION	CHKD	DATE
A	ORIGINAL ISSUE		19.05.09

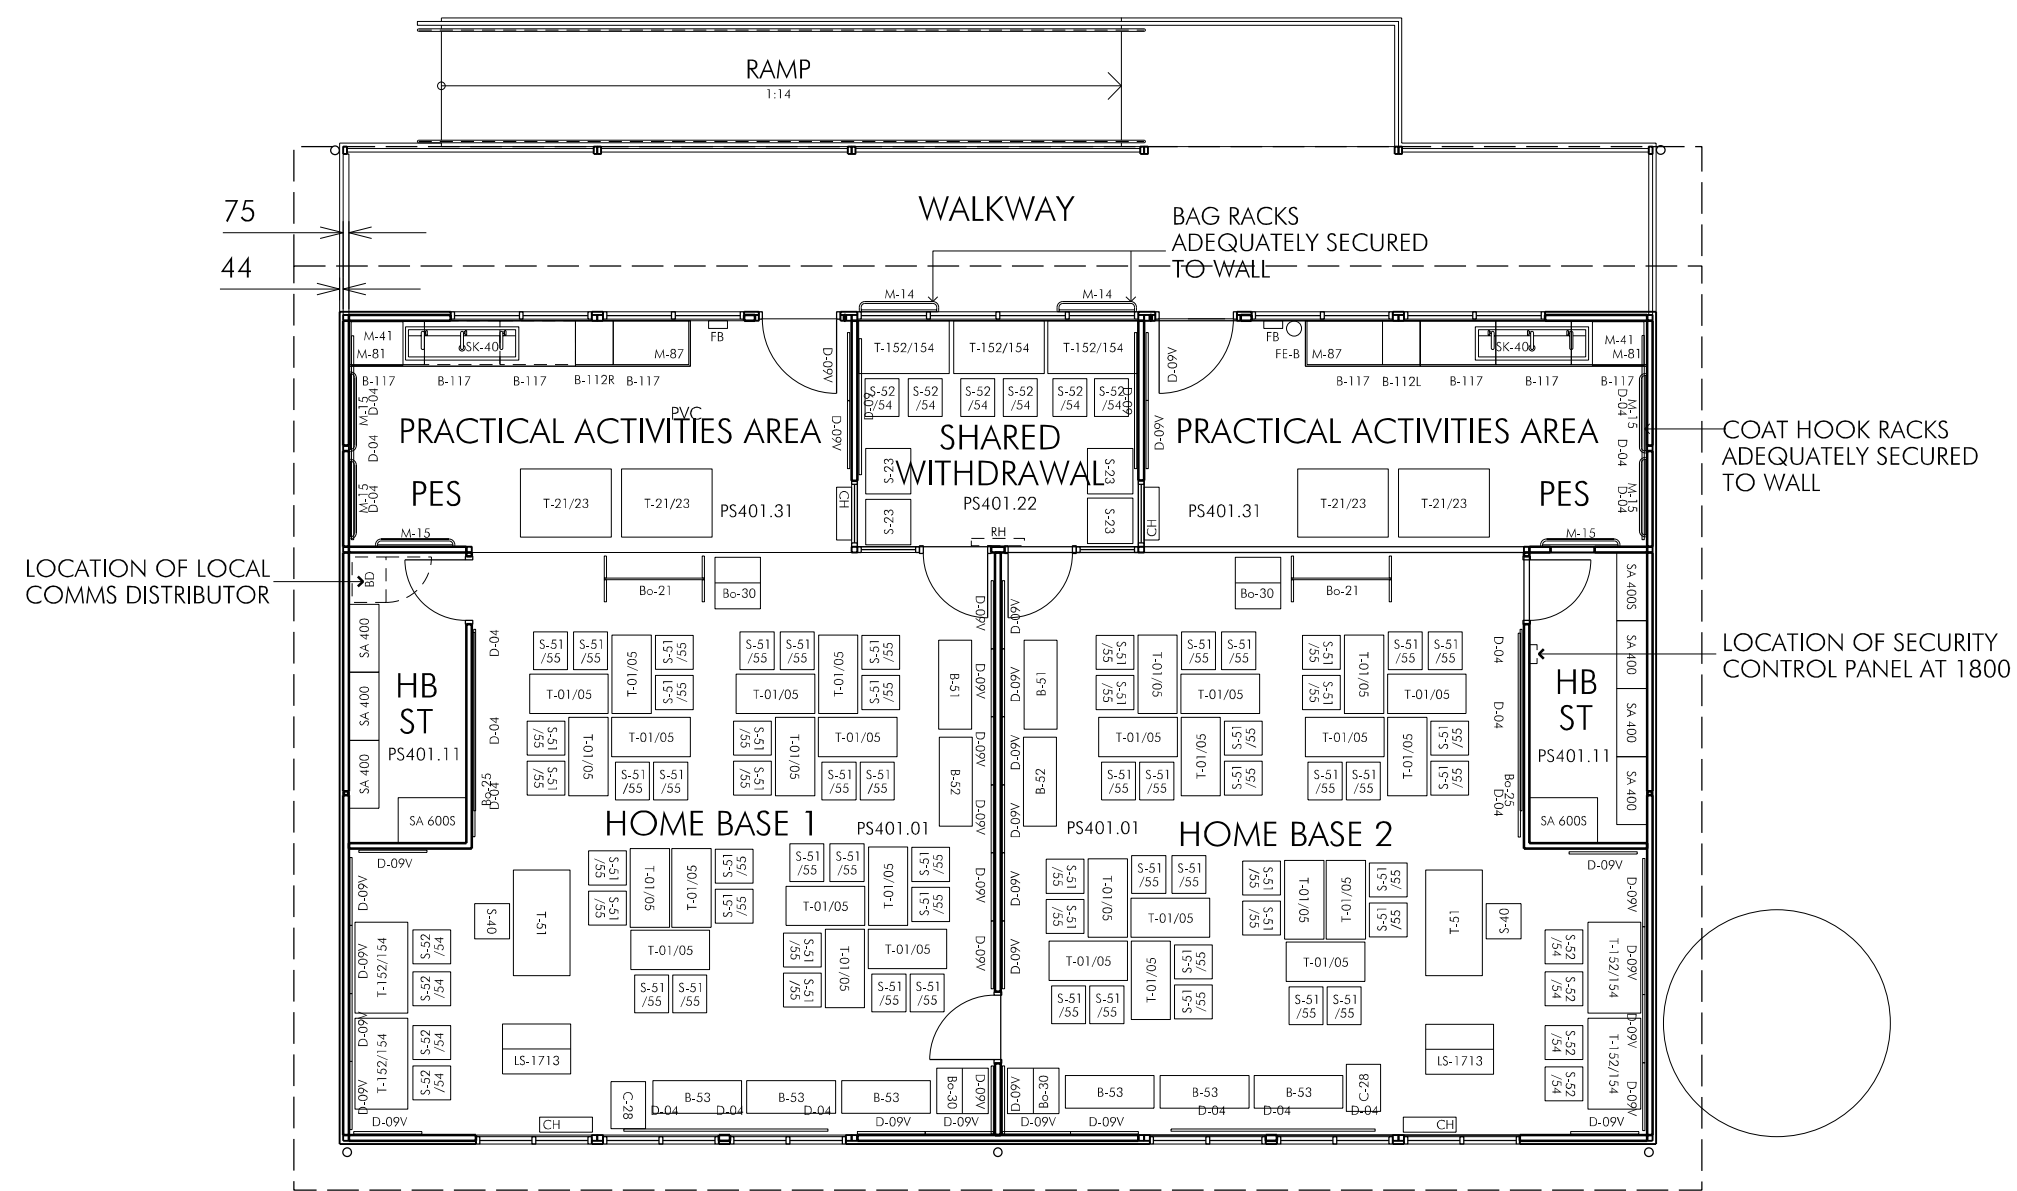

THESE DRAWINGS ARE FOR TENDER PURPOSES ONLY AND NOT FOR CONSTRUCTION. THESE DRAWINGS DESCRIBE THE DESIGN INTENT, DESIGN DETAILS AND FINISHES, SIZES AND RELATIONSHIPS OF ROOMS, BUILDING ENVELOPE AND ARCHITECTURAL EXPRESSION. THE SCHOOL FACILITIES STANDARDS MUST BE USED IN CONJUNCTION WITH THESE DRAWINGS.

EACH CODE NUMBER WITH A 'PS' PREFIX CORRESPONDS TO THE RELEVANT PRIMARY SCHOOL FACILITIES STANDARDS ROOM DATA SHEETS DESCRIBING THE FUNCTIONAL AND SERVICE REQUIREMENTS OF EACH ROOM WHICH ARE TO BE INCORPORATED INTO THE WORKS.

LEGEND		
AP ACCESS PANEL TERMINAL BOX	FVS VINYL FLOOR SHEETING	REC RECESSED CARPETING
BAE BALUSTRADE	GL GROUND LEVEL	ROB CORRUGATED METAL ROOF SHEETING
BLZ BUILDING LINER	HS HOME BASE	RSU ROOF SHEETING UNDERLAYER
CF CHANGING FANS	HC CLOSET HOOK	RWG RIGID ALUMINIUM RAINWATER GUTTER
CFC CORRUGATED FIBRE CEMENT	HP HANGING	WSP WATER SPLITTING DOWN PIPE
CH CONNECTION HEATER	LGA ADJUSTABLE GLASS LOUVER	SC SQUARE OR RECTANGULAR STEEL COLUMN
CCA ACQUISITION PLASTERBOARD CEILING	LGA LUMINARE	SCB SQUARE CEMENT Scribe
CPB PLASTERBOARD CEILING	PAA PRACTICAL ACTIVITIES AREA	SCF SCHEDULED FIBRE CEMENT Scribe
EB EPOXY BOND STAINLESS STEEL	PS PERSONAL EFFECTS STORE	SCS SCHEDULED STAINLESS STEEL Scribe
FB FIBRE BRICKSET	PVC PHOTOVOLTAIC CELL	SOV SCHEDULED STONE
FCP CARPET	RBC RIBBED ROOF	SI STONE
FCC CORRUGATED FIBRE CEMENT FLOOR SHEETING	RH ROBERT WALL MOLDED STRIP HEATER	WET CERAMIC WALL TILES
FL FINISHED FLOOR LEVEL	RO ROOF OVER	WFD WALL FEATURE (TYPE)
FG FINISH GRABING	RP RIG RACK	WFC CORRUGATED FIBRE CEMENT WALL SHEETING

Copyright in this drawing remains with the Minister for Commerce on behalf of the Crown in right of New South Wales. This drawing is provided for the purposes of the Building the Education Revolution Program only and may not be used for any other purpose without the express permission of the copyright owner. The user is responsible for ascertaining the accuracy and suitability of this drawing for their purposes. No responsibility is taken for any errors or omissions and any loss or liability suffered as a result of, or due to reliance on, this drawing. No responsibility is taken for data integrity, or file and system viruses as a result of the electronic transfer of this drawing. This statement is an integral part of this drawing. Reproduction of this drawing or any part of it without this statement being included in full will render the information shown in such reproduction invalid and not suitable for use. These documents were prepared for DDC procurement only.

PROJECT MANAGEMENT
PROGRAMS BRANCH

DESIGN DOCUMENTATION
BUILDING DESIGN SERVICES
EDUCATION FACILITIES RESEARCH GROUP


PETER MOULD
GOVERNMENT ARCHITECT

GRAEME HEAD
DIRECTOR - GENERAL



	BUILDING THE EDUCATION REVOLUTION MDR - HOME BASE FURNITURE PLAN		SCALE 1:100 NO IN SET
	DATE 19.05.09 DRAWN GAO VERIFIED PTS	SHEET NO MDRHB03	

 A3



CROWN COPYRIGHT 2003
NSW MINISTER FOR COMMERCE